
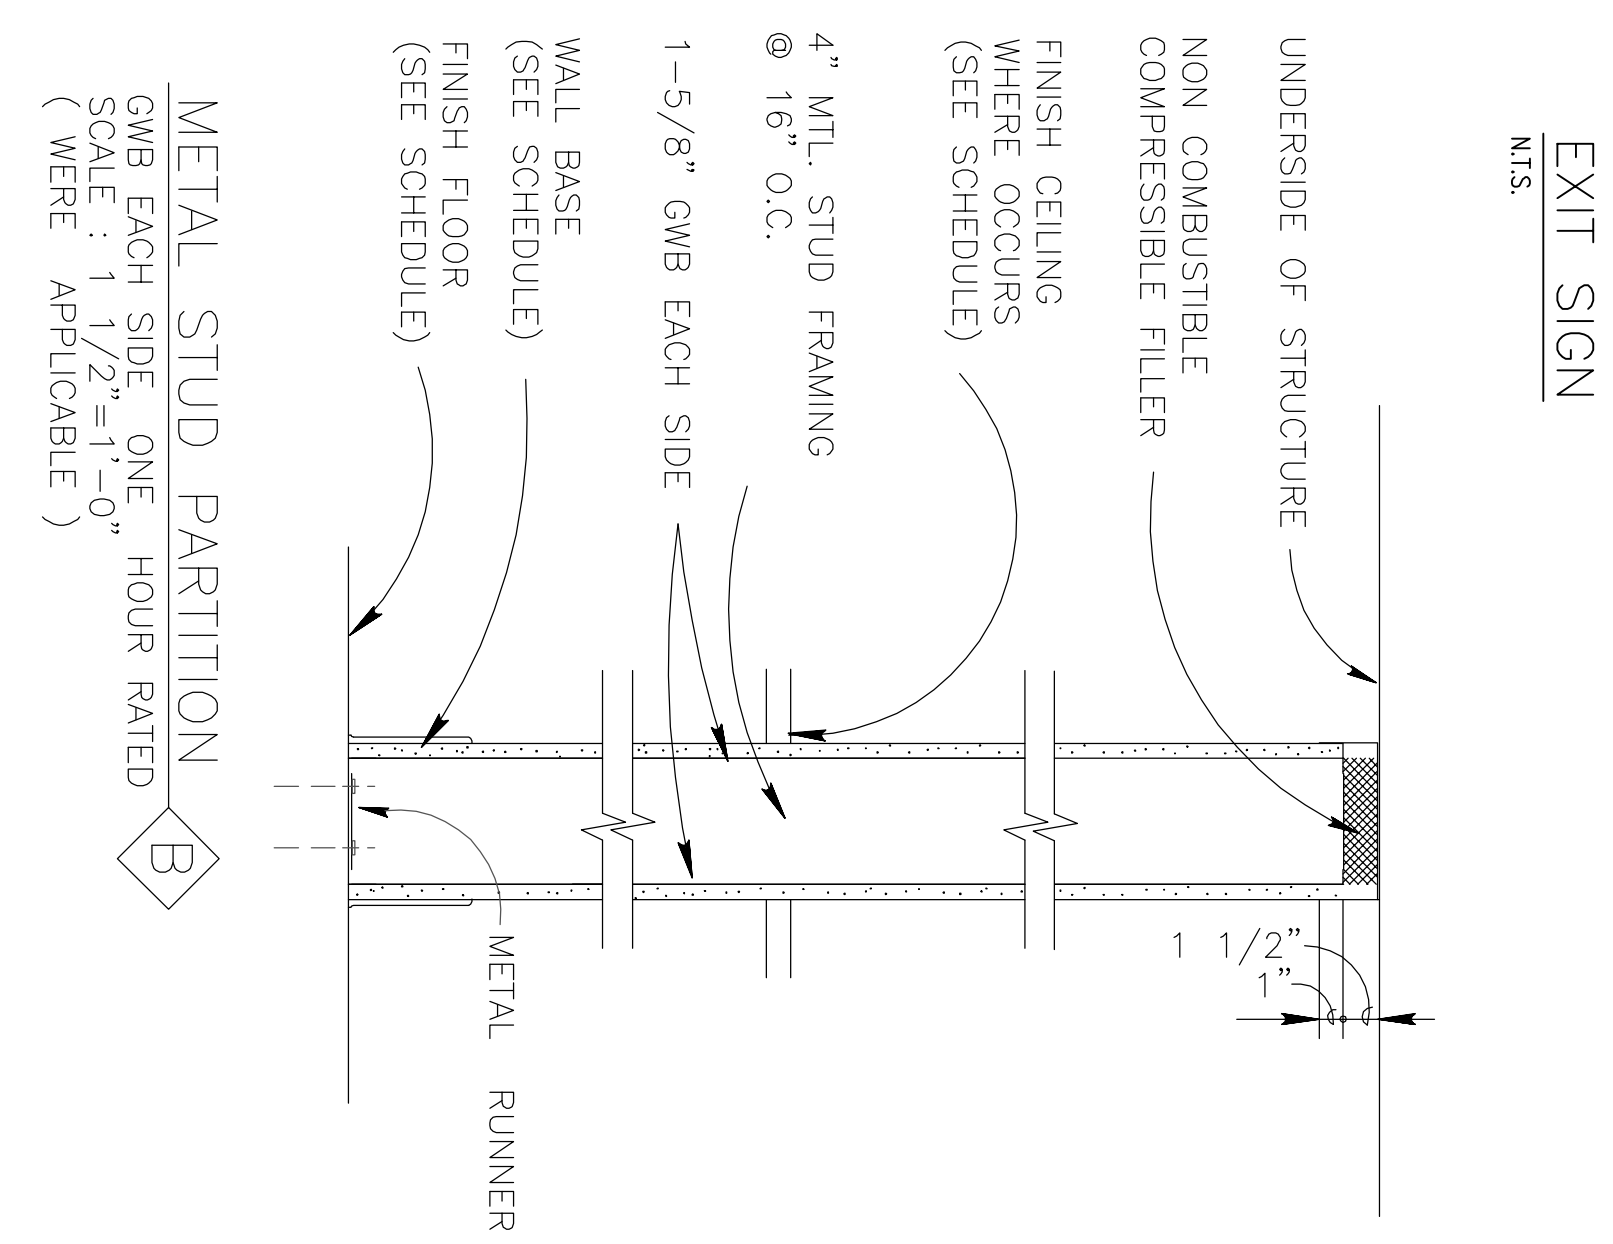
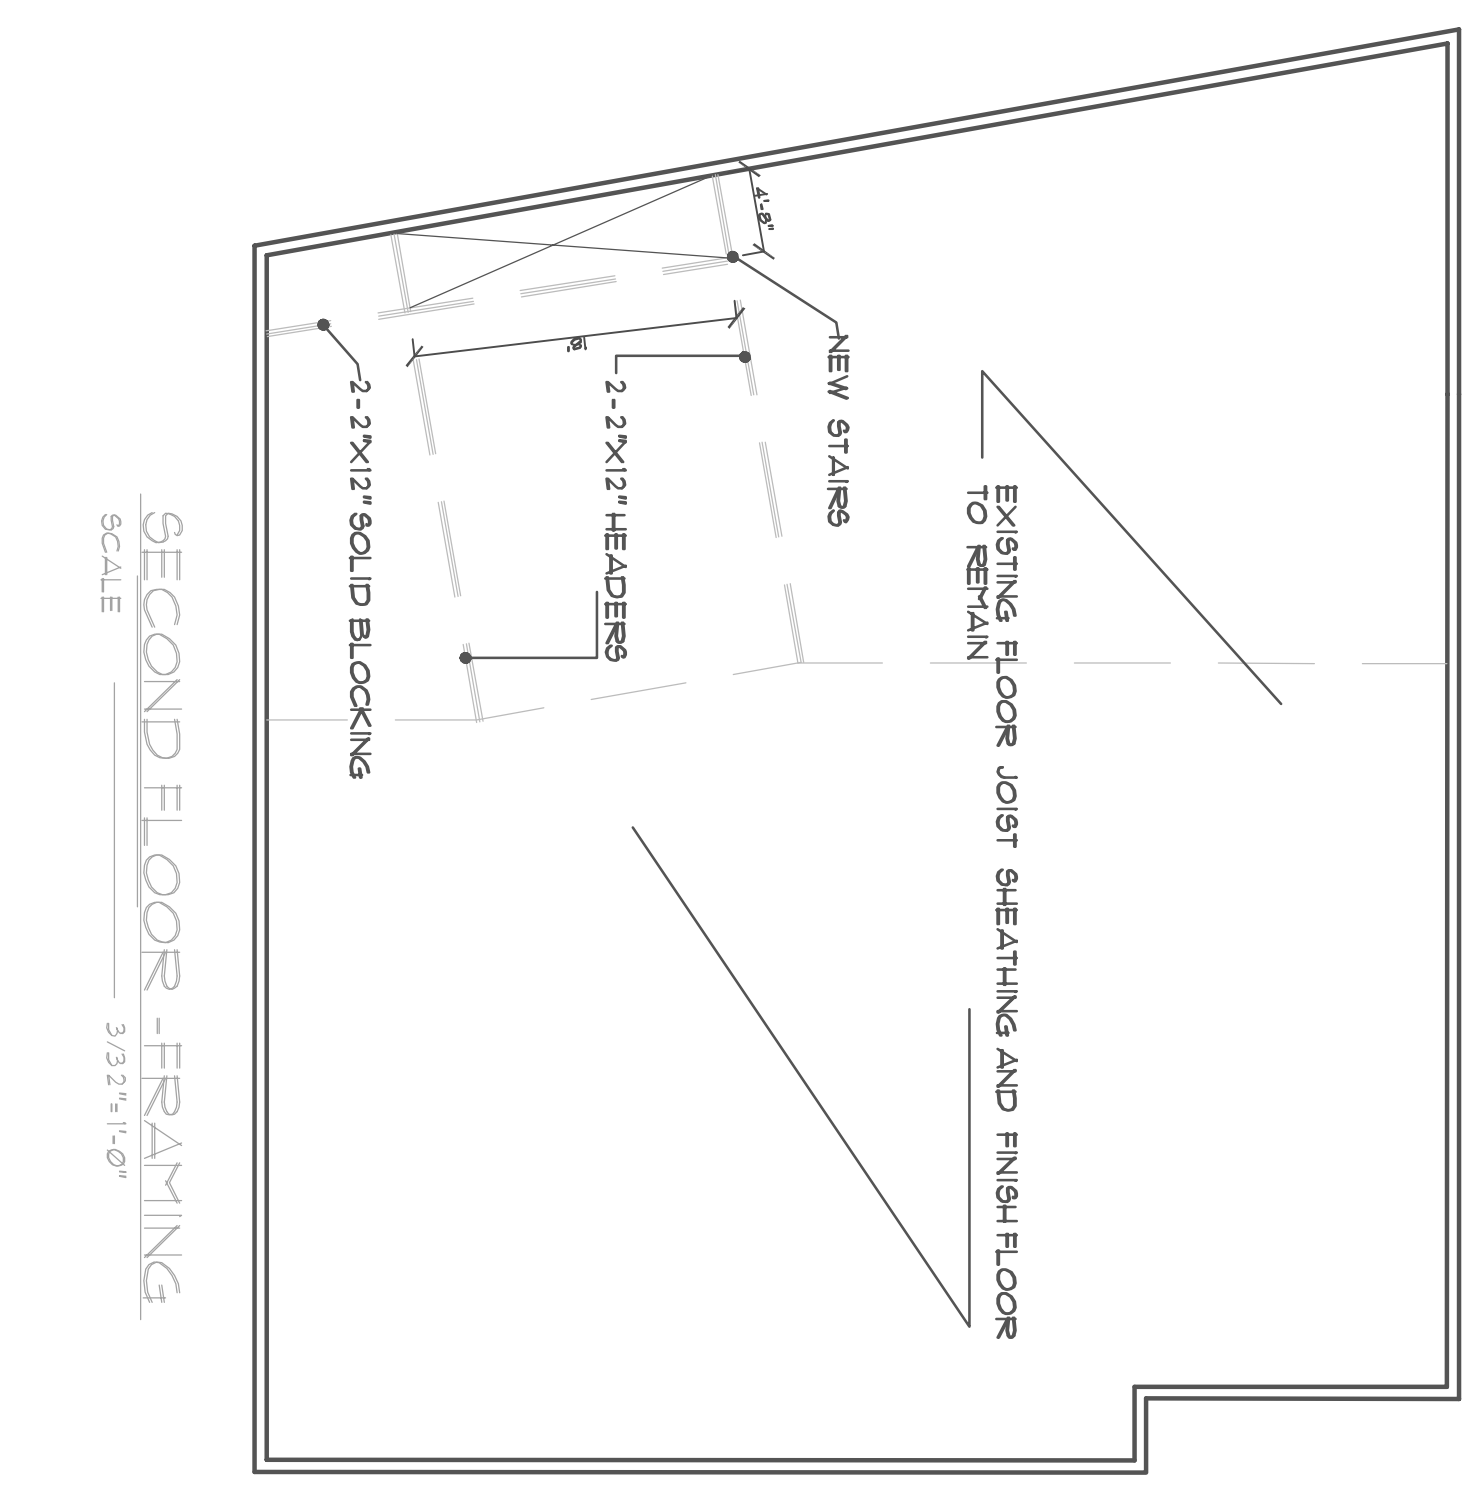
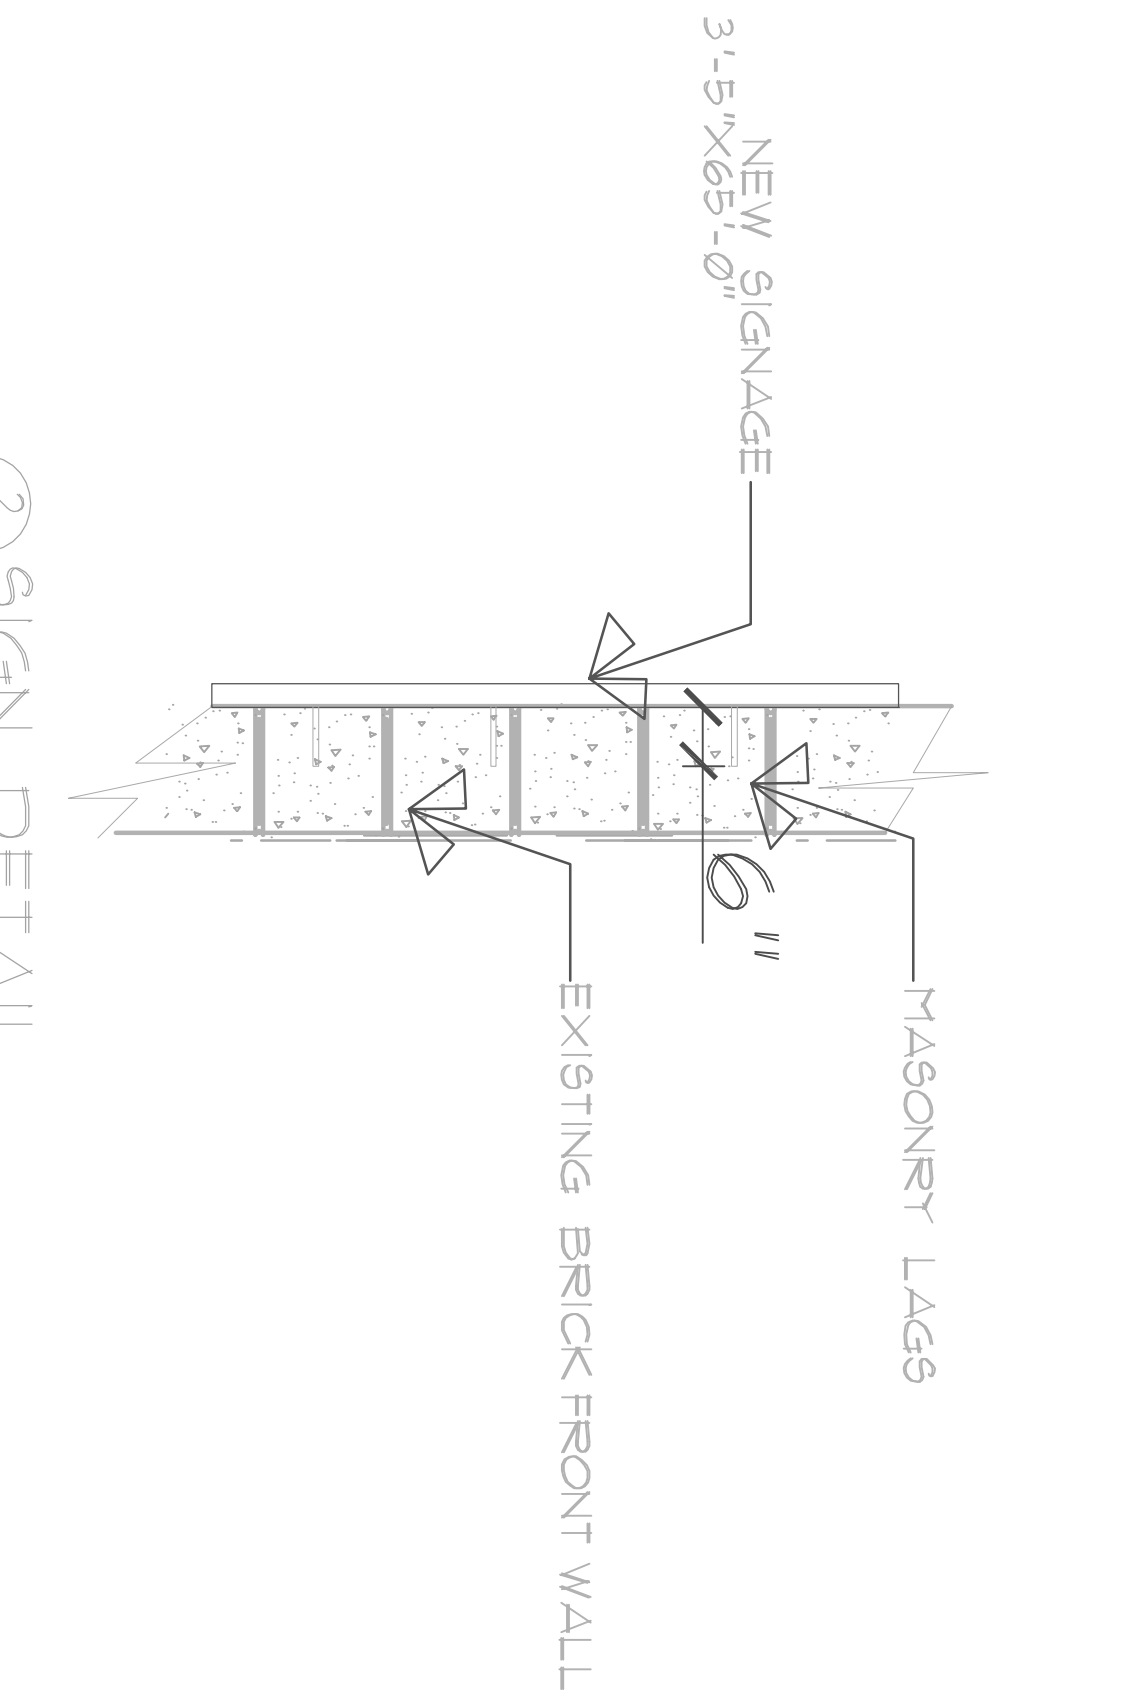
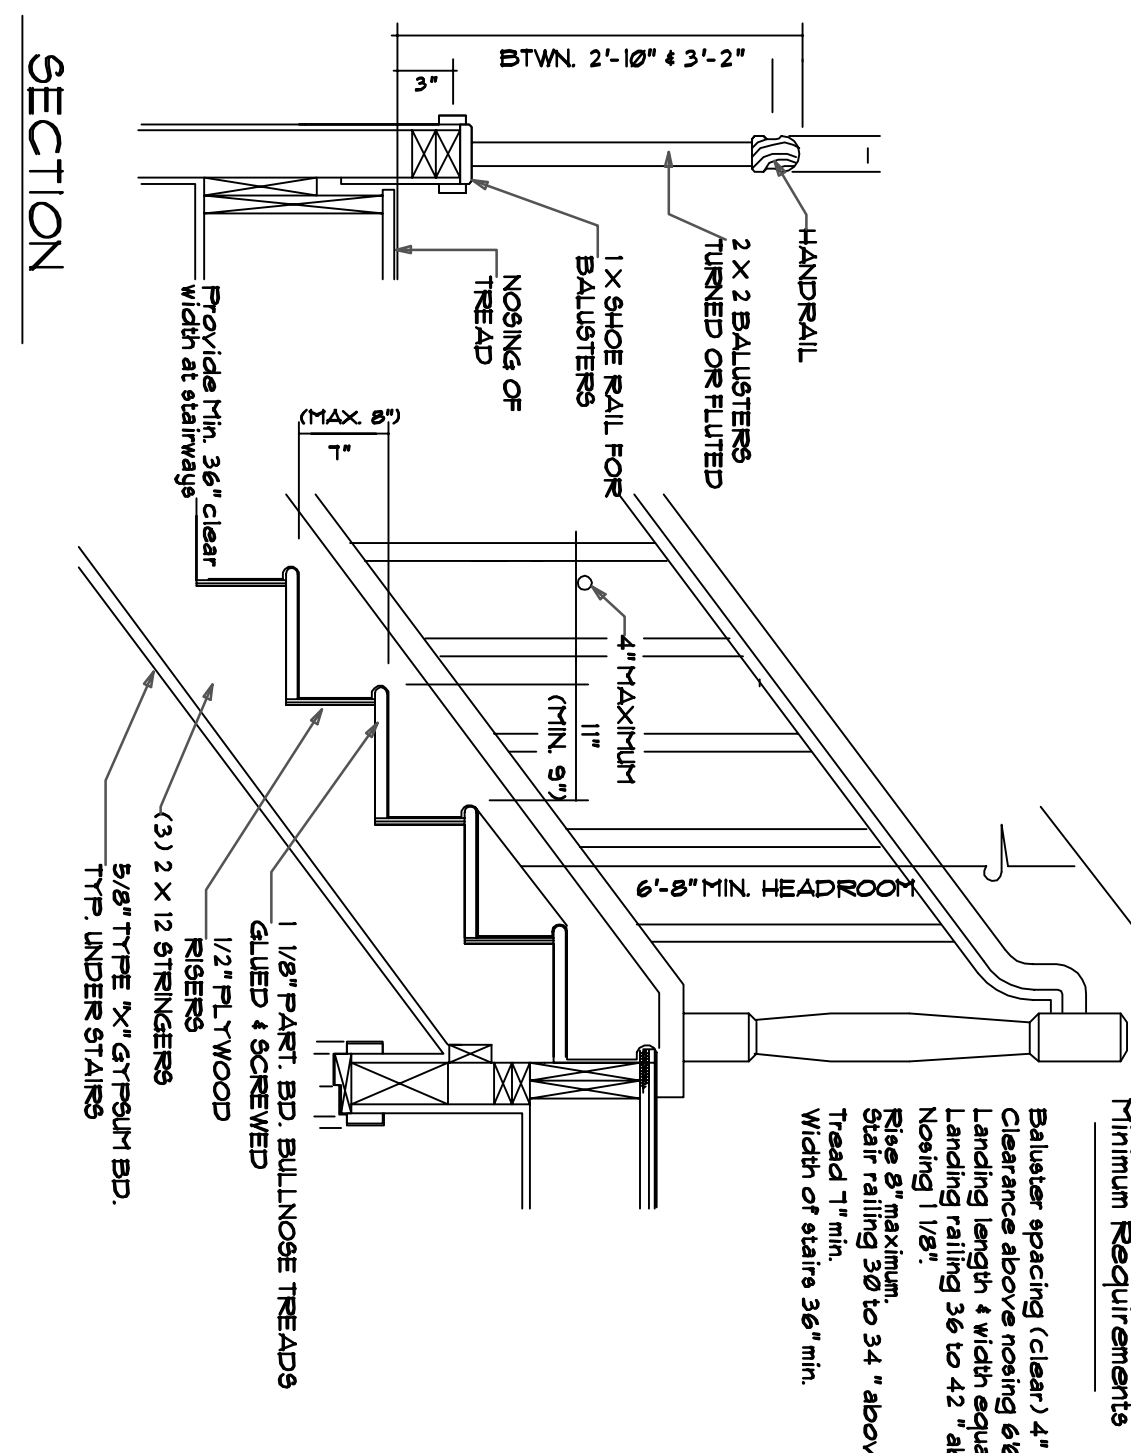


LEGEND

4" METAL STUDS @16" O.C.
5/8" G.W.B
TYP X FIRE RATED -1-HOUR (5/8")

⊕ LIGHT SWITCH
CMU WALL
● FRESH AIR VENT

EMERGENCY LIGHTS
⊕D HARD WIRED SMOKE DET
W WINDOW
H= HEADER HT.
S= SILL HEIGHT

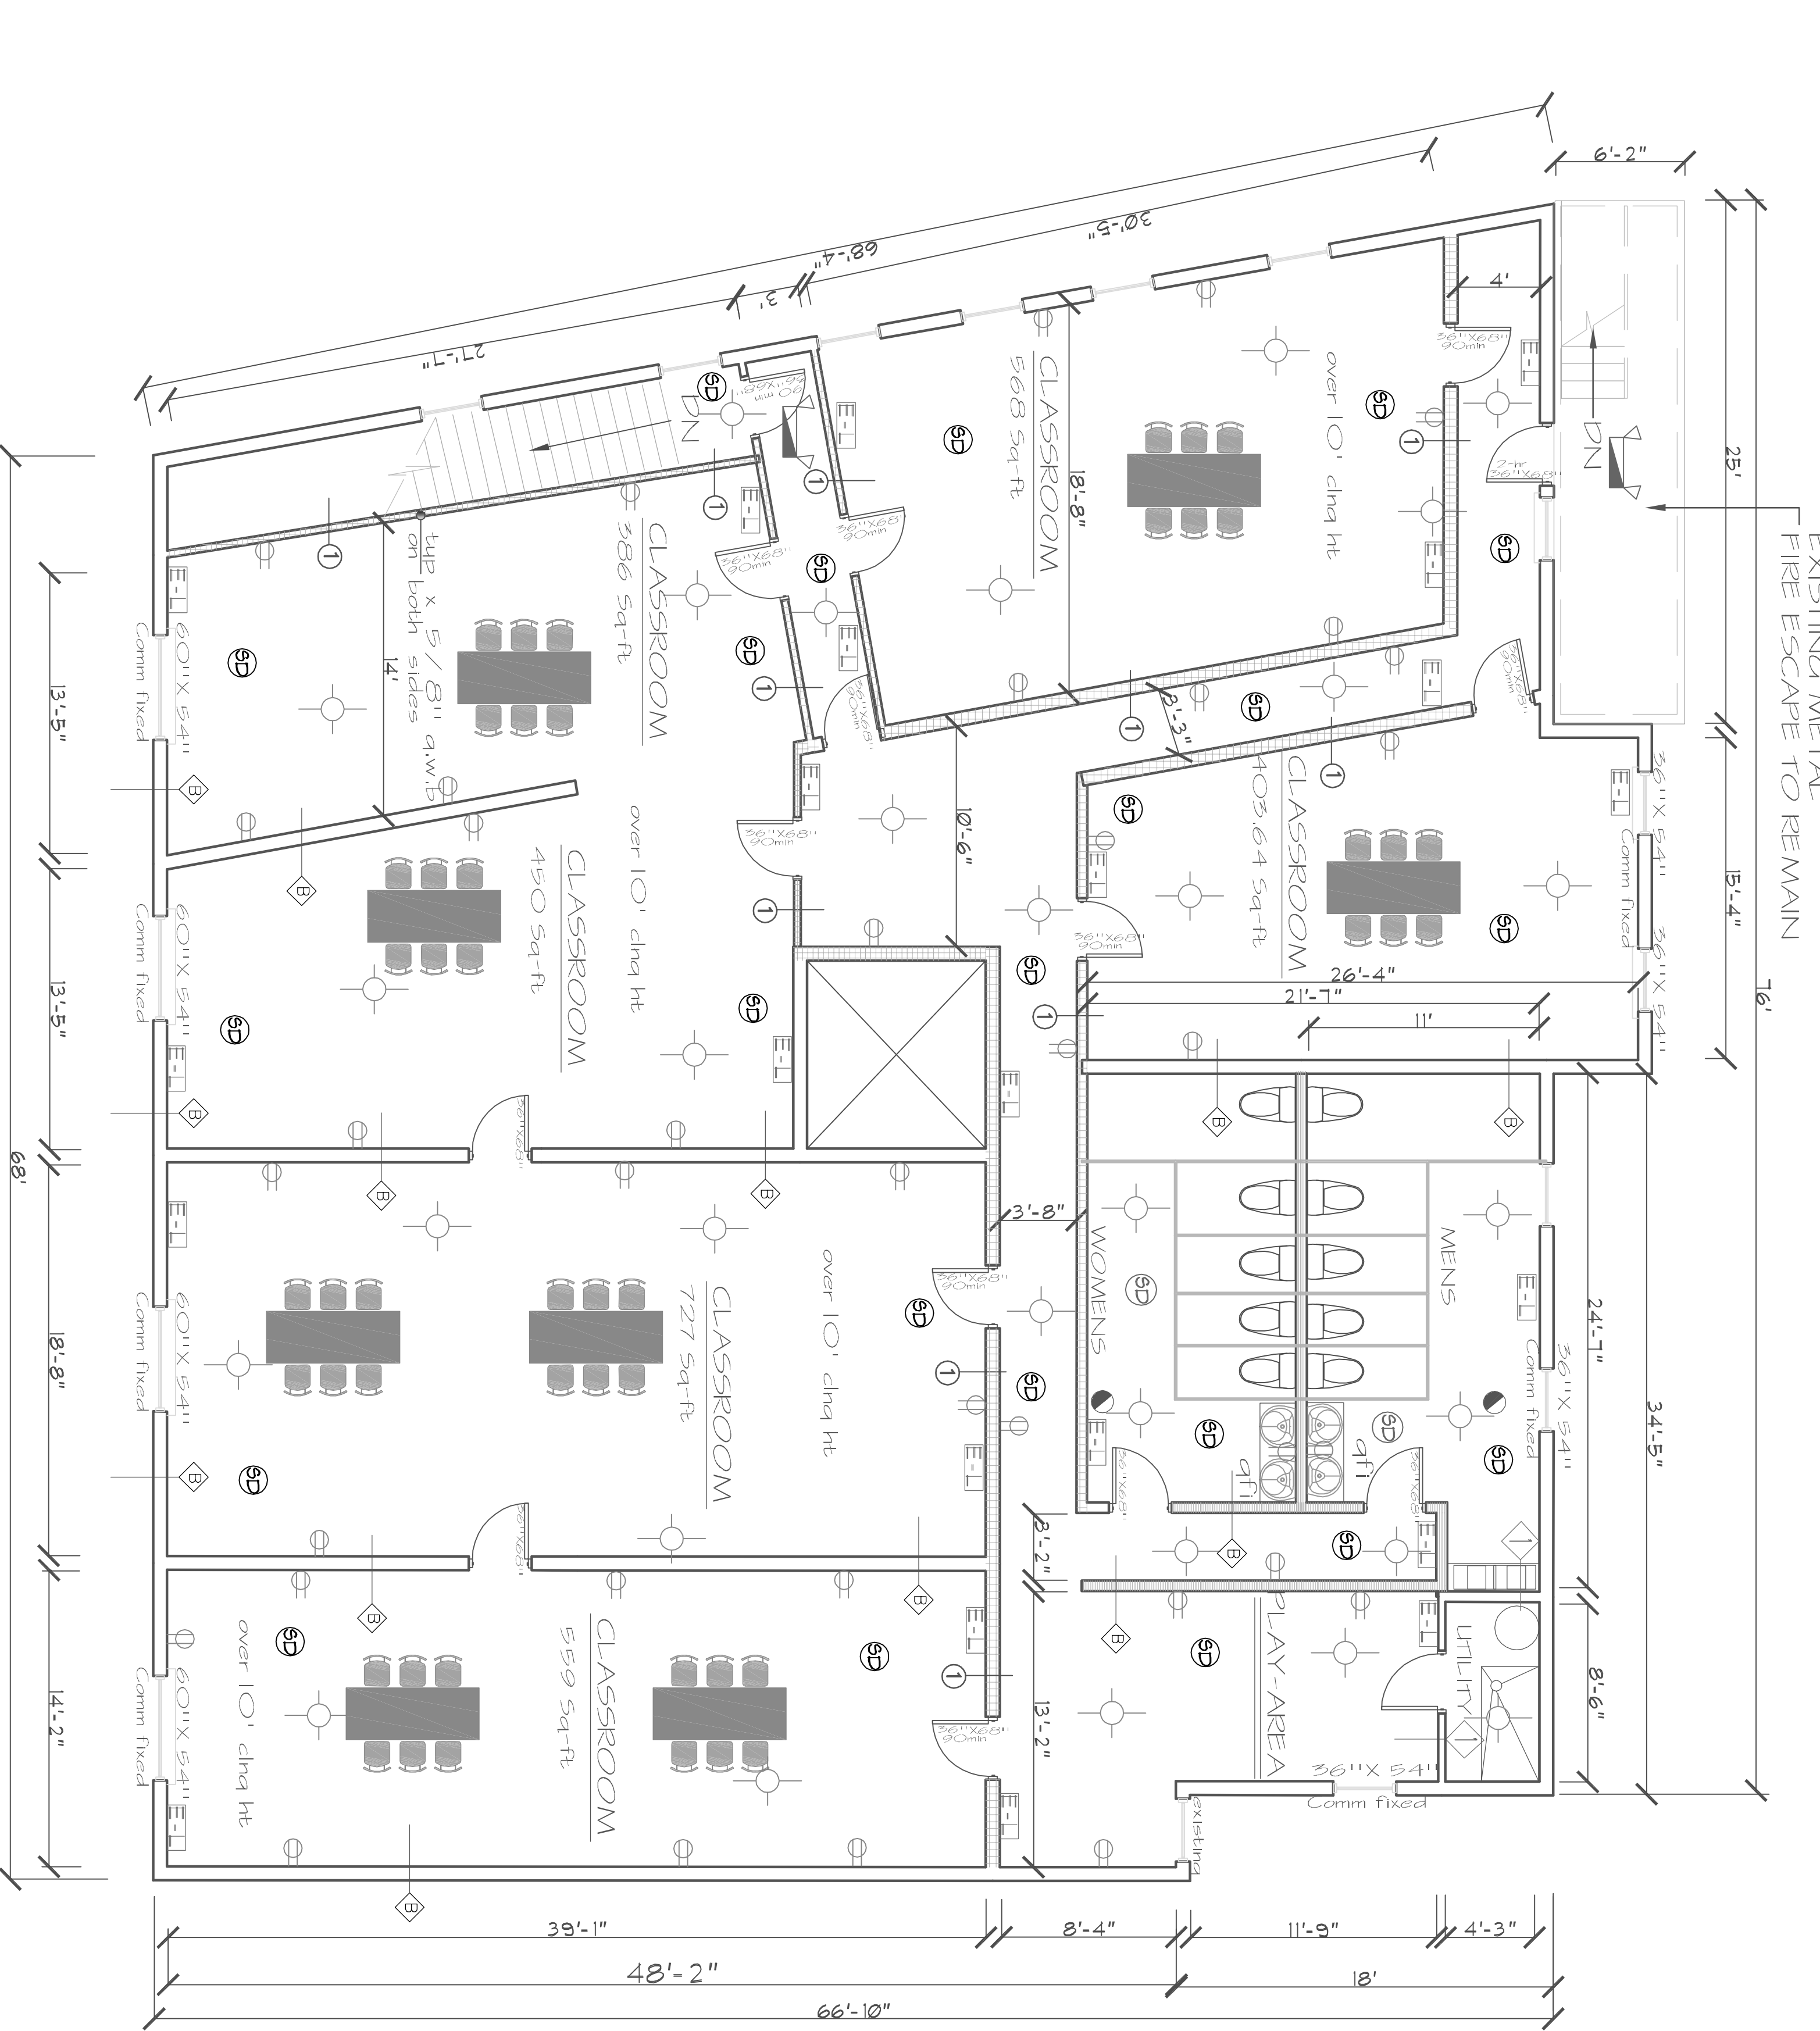

FLOOR PLANS FOR DAYCARE

COMMERCIAL BUILDING

6053-59 WOODLAND AVENUE
PHILA.PA OWNER:

REVISIONS:

DATE	DESCRIPTION

THE CONTRACTOR IS RESPONSIBLE FOR OBTAINING ALL NECESSARY PERMITS AND APPROVALS FROM ALL AGENCIES AND DEPARTMENTS CONCERNED WITH THE PROJECT. THE CONTRACTOR SHALL BE RESPONSIBLE FOR OBTAINING ALL NECESSARY PERMITS AND APPROVALS FROM ALL AGENCIES AND DEPARTMENTS CONCERNED WITH THE PROJECT. THE CONTRACTOR SHALL BE RESPONSIBLE FOR OBTAINING ALL NECESSARY PERMITS AND APPROVALS FROM ALL AGENCIES AND DEPARTMENTS CONCERNED WITH THE PROJECT.

SEALED

Gore Drafting, Inc.
design and construction planning services
PO BOX 27591
PHILADELPHIA, PA 19118

tele: 267-259-1420
fax: 215-689-4101
rdraftmen@AOL.COM

DRAWN BY: R.A.G. DATE: JUNE 23, 2011 PROJECT NUMBER: 20110623-1

PWG. NO.:
A 2
SHEET 2 OF 2